




PLAN SHOWING THE PROPOSED CONSTRUCTION OF A COLLEGE BUILDING GROUND FLOOR ,FIRST FLOOR & SECOND FLOOR PLAN FOR J.R.S COLLEGE OF EDUCATION IN S.F NO:1339/2&1339/2B,U.D.R NO:638/2A1,638/2A2,638/2B2&638/2B5,AT ANNAMANGALAM VILLAGE & PANCHAYAT, VEPPANTHATTAI TALUK,PERAMBALUR DISTRICT.

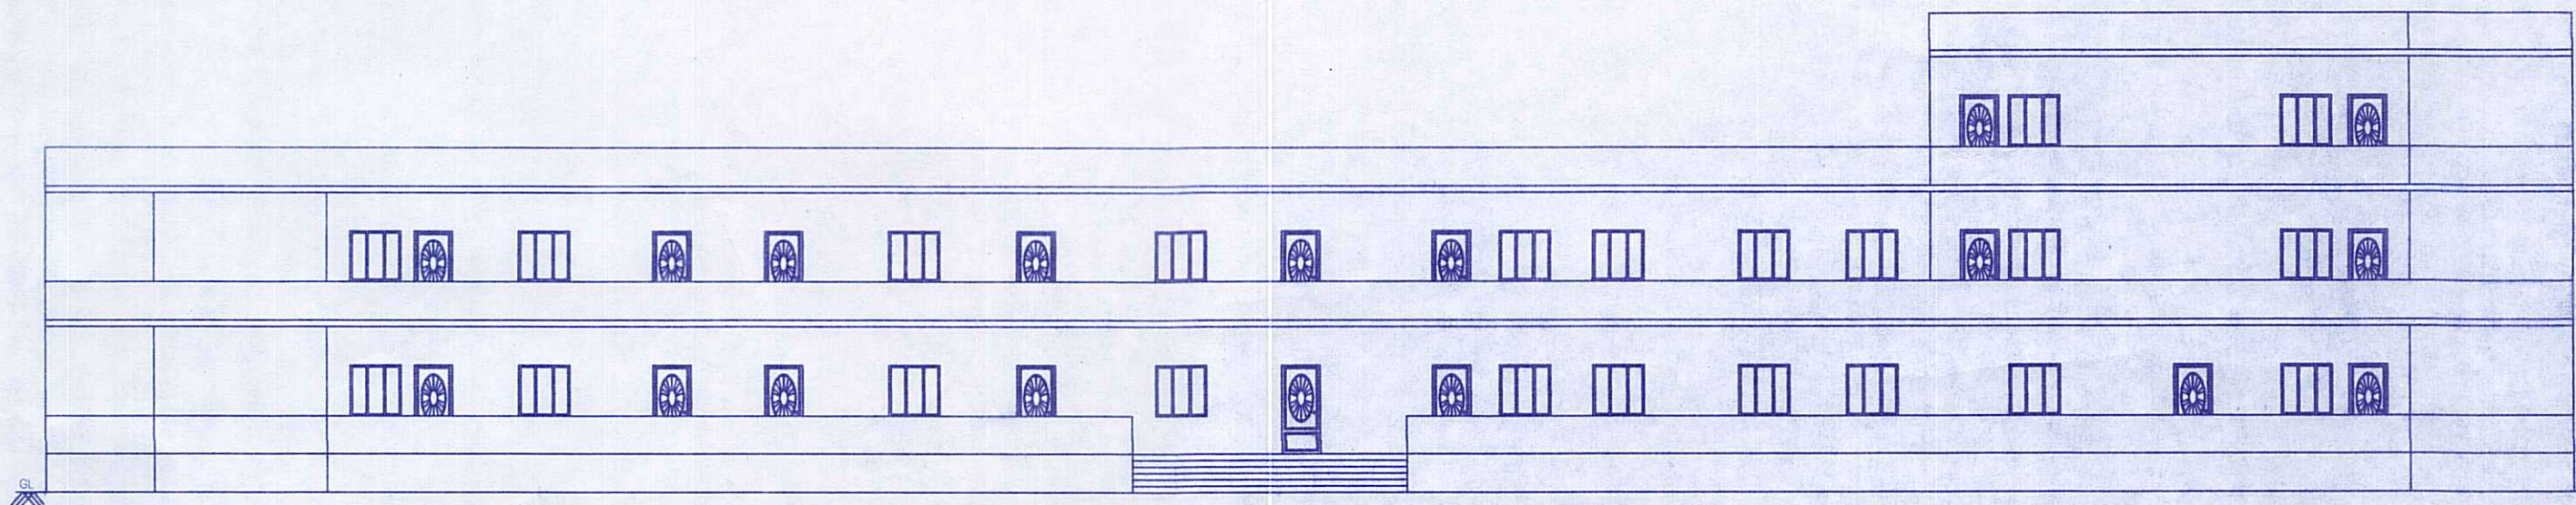


ELEVATION

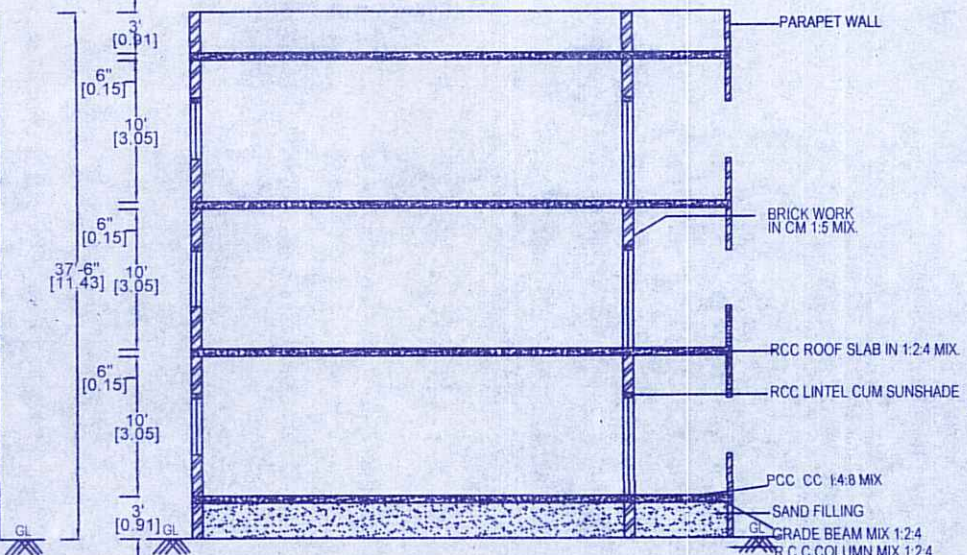


SECTION ON 'AB'

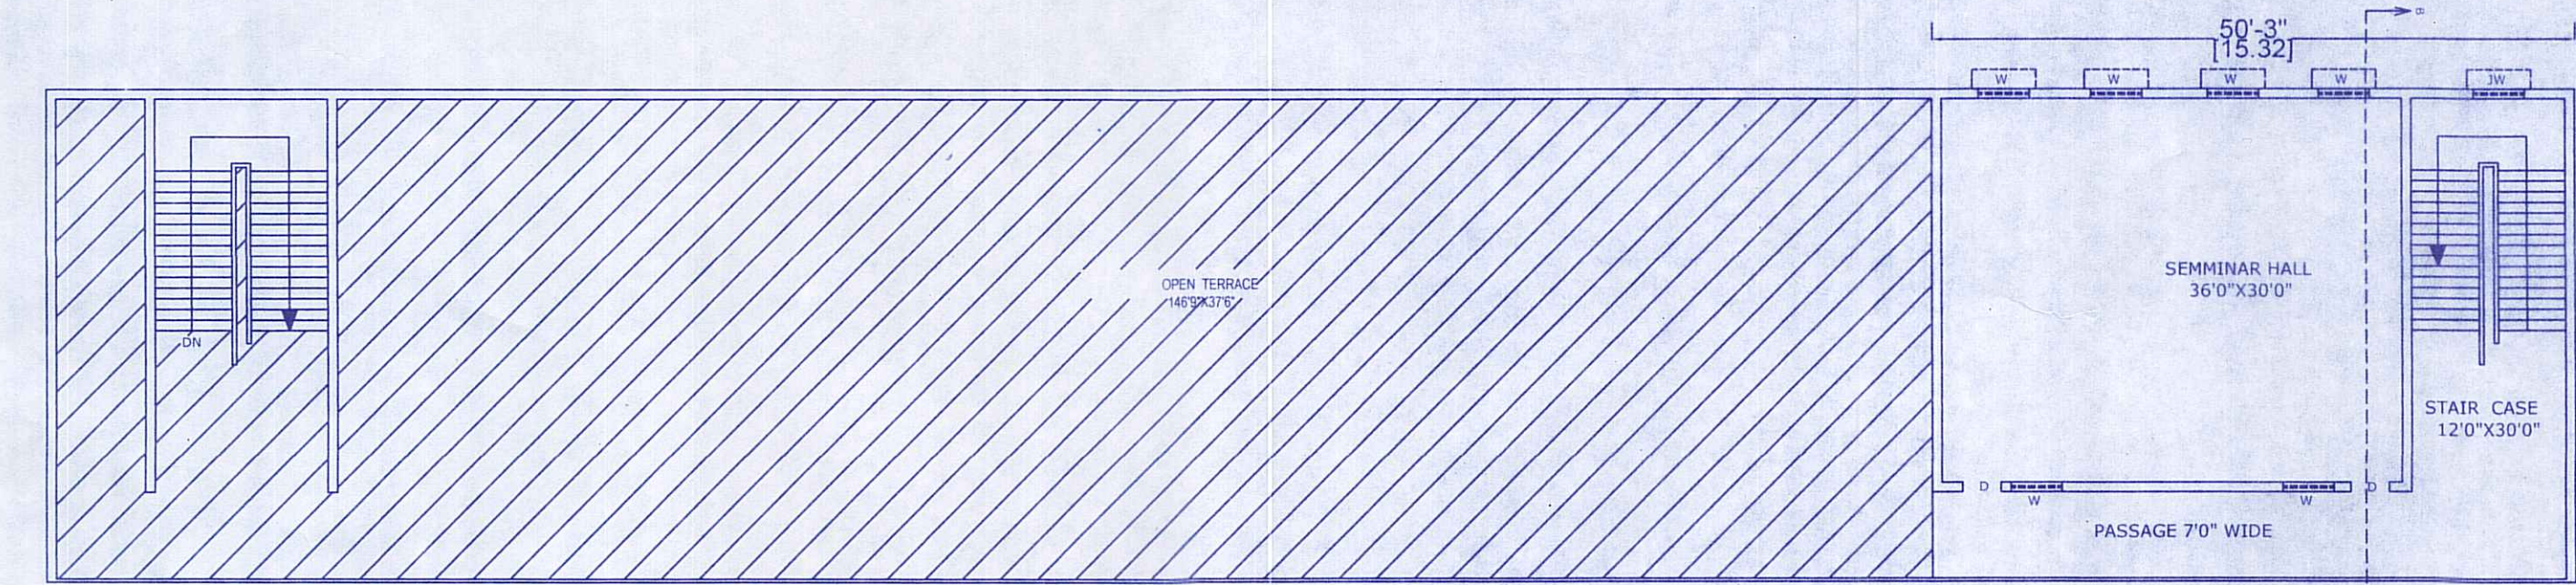








SECOND FLOOR PLAN

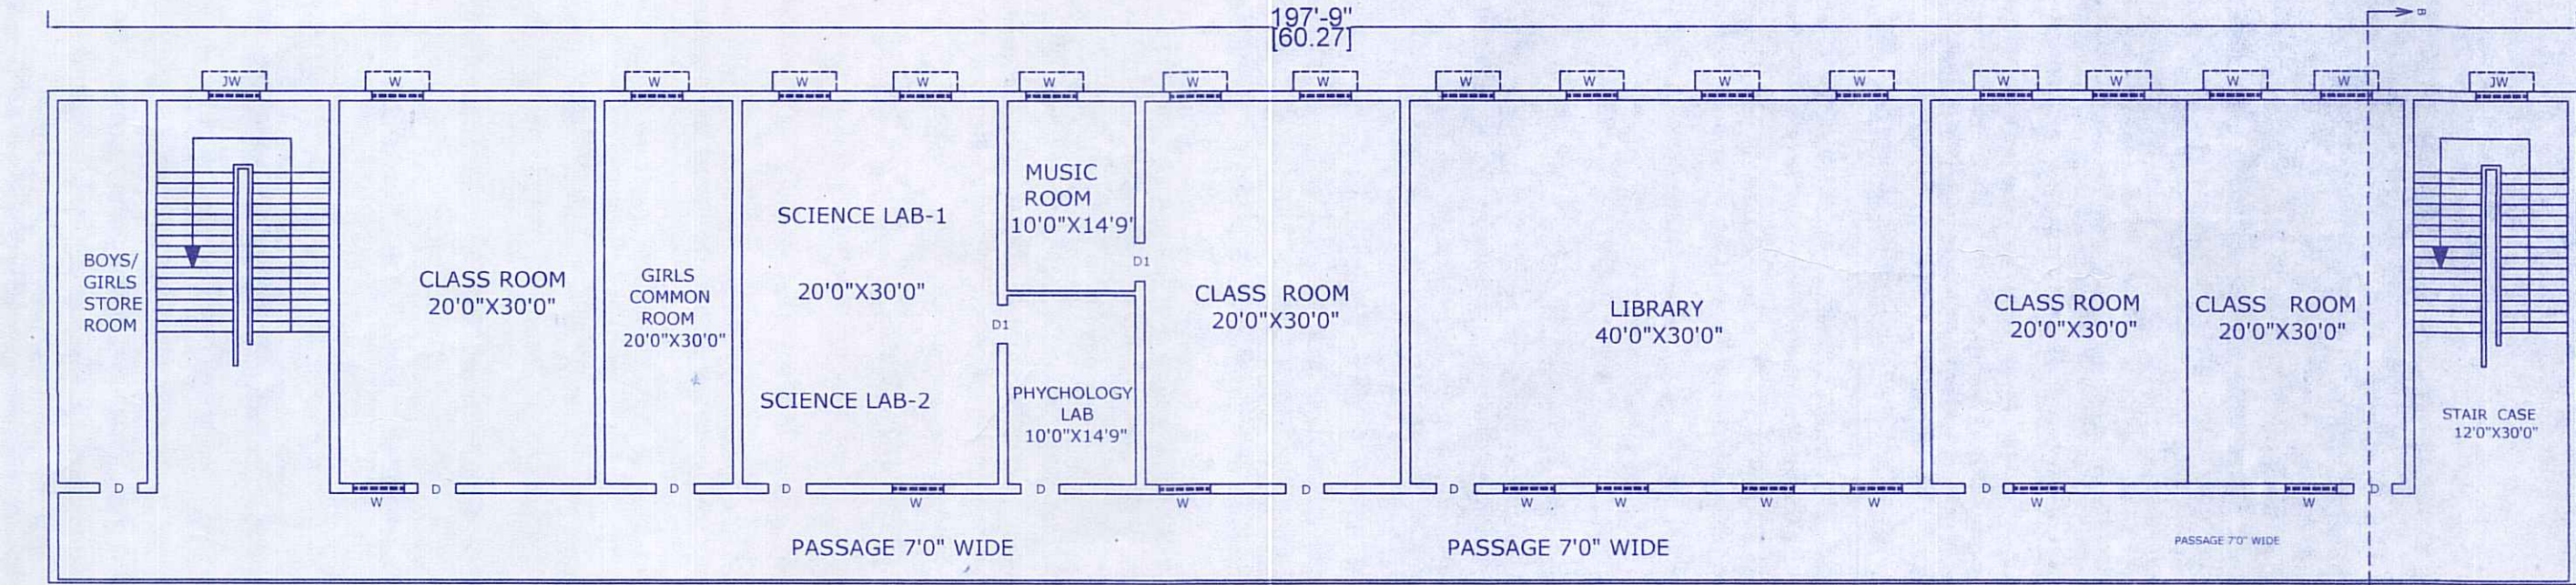

FIRST FLOOR PLAN

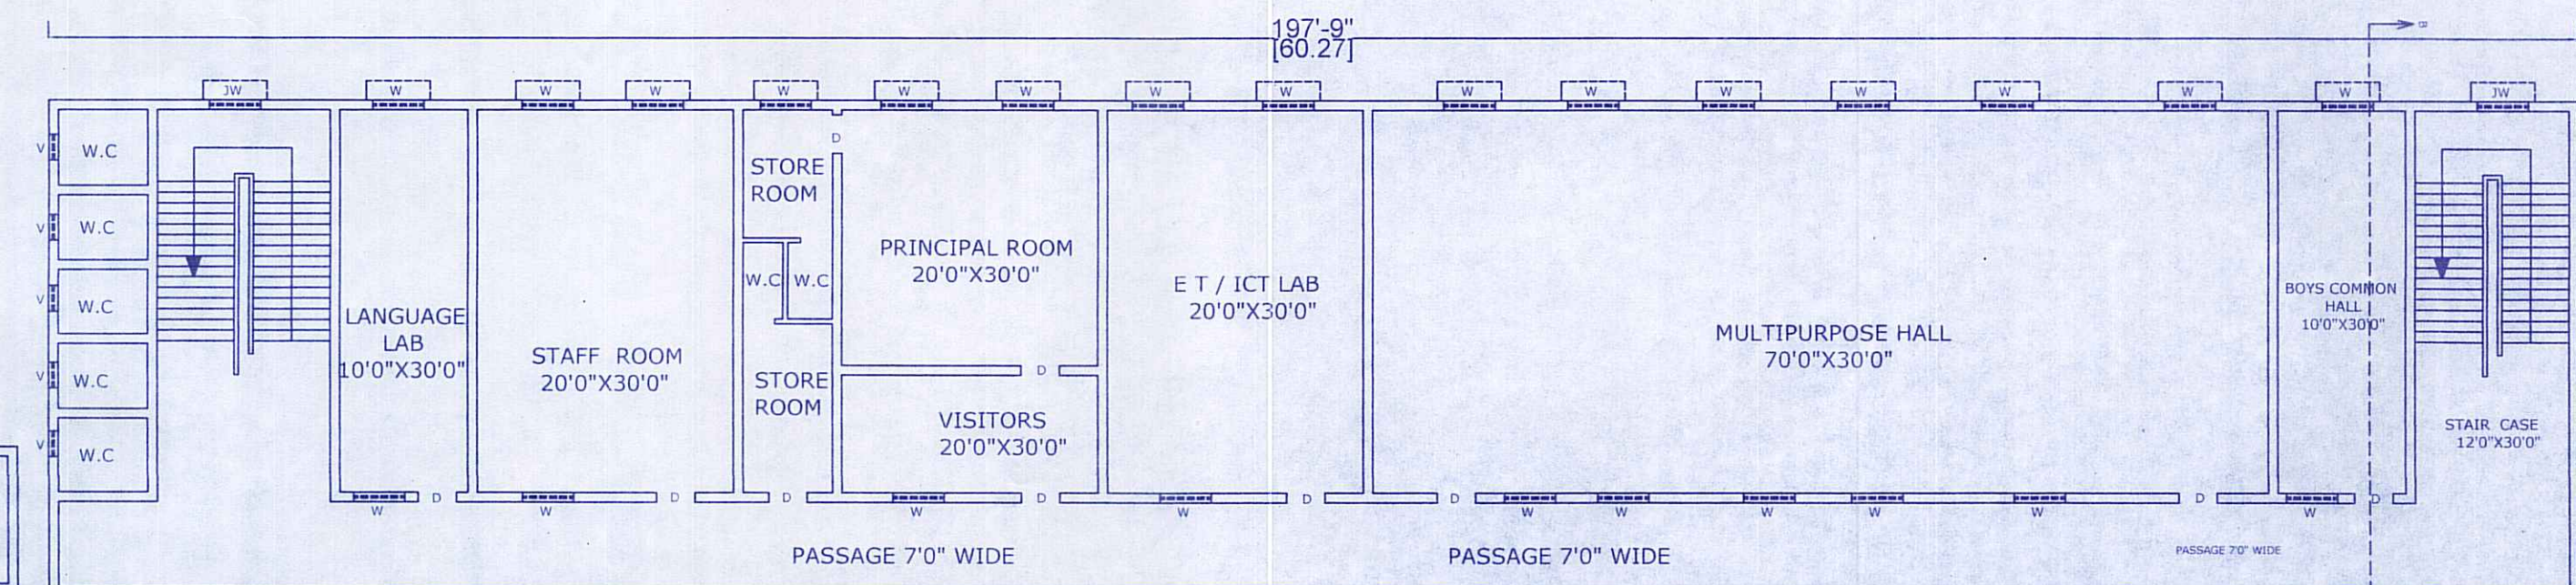

GROUND FLOOR PLAN

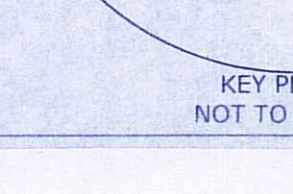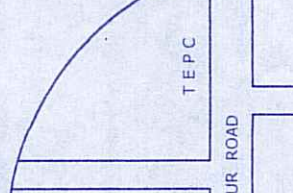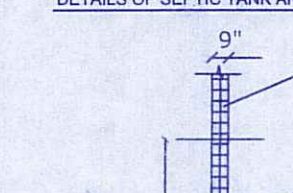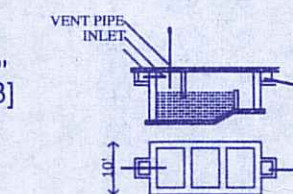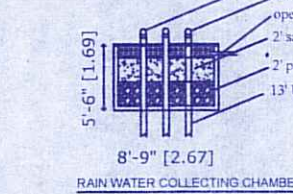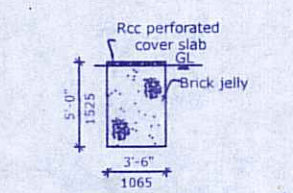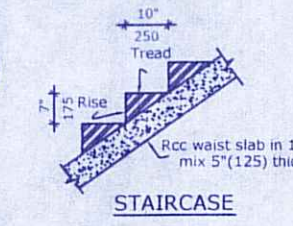

APPROVING AUTHORITY

திருவள்ளூர் செயல்பாட்டு அமைச்சு
5.12.2006

SCALE 1 : 100

SL.N	DESCRIPTION	FEET	METER
MD	MAIN DOOR	4'0"X7'0"	(1.22x2.10m)
D	DOOR	3'3"X7'0"	(1.00x2.10m)
D1	DOOR	2'6"X6'6"	(0.76x2.00m)
W	WINDOW	4'0"X4'0"	(1.22x1.22m)
V	VENTILATOR	2'0"X2'0"	(0.61x0.61m)
JW	JOLLY WINDOW	5'0"X15'0"	(1.52x5.00m)

AREA STATEMENT:

	SQFT	SQM
TOTAL LAND AREA	319588.00	29701.49
GROUND FLOOR AREA	7613.00	707.53
FIRST FLOOR AREA	7613.00	707.53
SECOND FLOOR AREA	1925.00	178.83
TOTAL BUILTUP AREA	17151.00	1593.89

COLOR INDEX

1. SITE BOUNDARY SHOWN IN ☐

2. EXISTING BUILDING SHOWN IN ☐

3. PROPOSED BUILDING SHOWN IN ☐

4. EXISTING ROAD SHOWN IN ☐

Notes:

1. WATER STORAGE TANK TO BE PROVIDED

2. SOLAR WATER HEATER SYSTEM TO BE PROVIDED

3. 'U' TRAP SEPTIC TANK DESIGN TO BE PROVIDED

4. WASTE WATER USED FOR GARDEN PURPOSE

OWNER : J.R.S COLLEGE OF EDUCATION, ANNAMANGALAM - 621 102, PERAMBALUR DIST. TAMILNADU

ENGINEER : G. MURUGESAN, E.E., LICENSED SURVEYOR, CONSULTING ENGINEER, PERAMBALUR - 621 212. Cell : 90471 91905